


ROOFTOP PACKAGED UNIT SCHEDULE (BY L.L.)

MARK	MANUFACTURER & MODEL	FAN SELECTION				E.A.T. DB/WB	COOLING CAP.		HEATING CAP.		ELECTRICAL					EER	SEER	LOCATION	SERVICE	NOTES	WEIGHT (LBS)
		CFM	O.A.	E.S.P.	MOTOR H.P.		NOMINAL (TON)	TOTAL/SENS (MBH)	KW	STAGES	V	PH	Hz	MCA	MOCP						
RTU-1	TRANE THC120F	4000	TBD	1.0	2.75	80/67	10	117/89.6	40.6	2	208	3	60	151.4	175	12.4	-	ROOF	CAFE	1,2,3,4,5,6,7,8,9,10	1500
RTU-2	TRANE THC120F	4000	TBD	1.0	2.75	80/67	10	117/89.6	40.6	2	208	3	60	151.4	175	12.4	-	ROOF	BACKBAR/ WORKROOM	1,2,3,4,5,6,7,8,9,10	1500
NOTES: 1. NEW ELECTRIC COOLING / ELECTRIC HEAT ROOFTOP PACKAGED UNIT BY LANDLORD. VERIFY FINAL LOCATION AT JOBSITE. 2. HIGH EFFICIENCY. DOWN DISCHARGE CONFIGURATION. 3. MOUNT ON CURB WITH NEW ROOF OPENING. 4. PROVIDE WITH FACTORY INSTALLED UNIT MOUNTED DISCONNECT SWITCH. 5. PROVIDE WITH FACTORY INSTALLED NON-POWERED CONVENIENCE SERVICE OUTLET (115V GFCI). 6. PROVIDE WITH FACTORY INSTALLED ENTHALPY TYPE ECONOMIZER. 7. PROVIDE SMOKE DETECTOR IN RETURN AIR DUCT TO SHUT DOWN UNIT UPON DETECTION. 8. PROGRAMMABLE THERMOSTAT WITH REMOTE SENSOR. SEE CONTROLS SPEC 9. PROVIDE WITH HAIL GUARDS 10. PROVIDE WITH POWER EXHAUST																					


EXHAUST FAN SCHEDULE (BY L.L.)

MARK	SERVICE	MAX. CFM	PLAN CFM	RPM	ESP (IN WG)	DRIVE	SONES (MAX)	MOTOR			MANUFACTURER	MODEL	NOTES
								VOLTAGE	PHASE	HP			
EF-1	RESTROOMS / OVENS	500	TBD	1405	0.31	DIRECT	6.2	115	1	1/10	GREENHECK	G-090-VG	1,2
NOTES: 1. PROVIDE WITH FACTORY ROOF CURB AND BACKDRAFT DAMPER 2. PROVIDE WITH SPEED CONTROLLER													

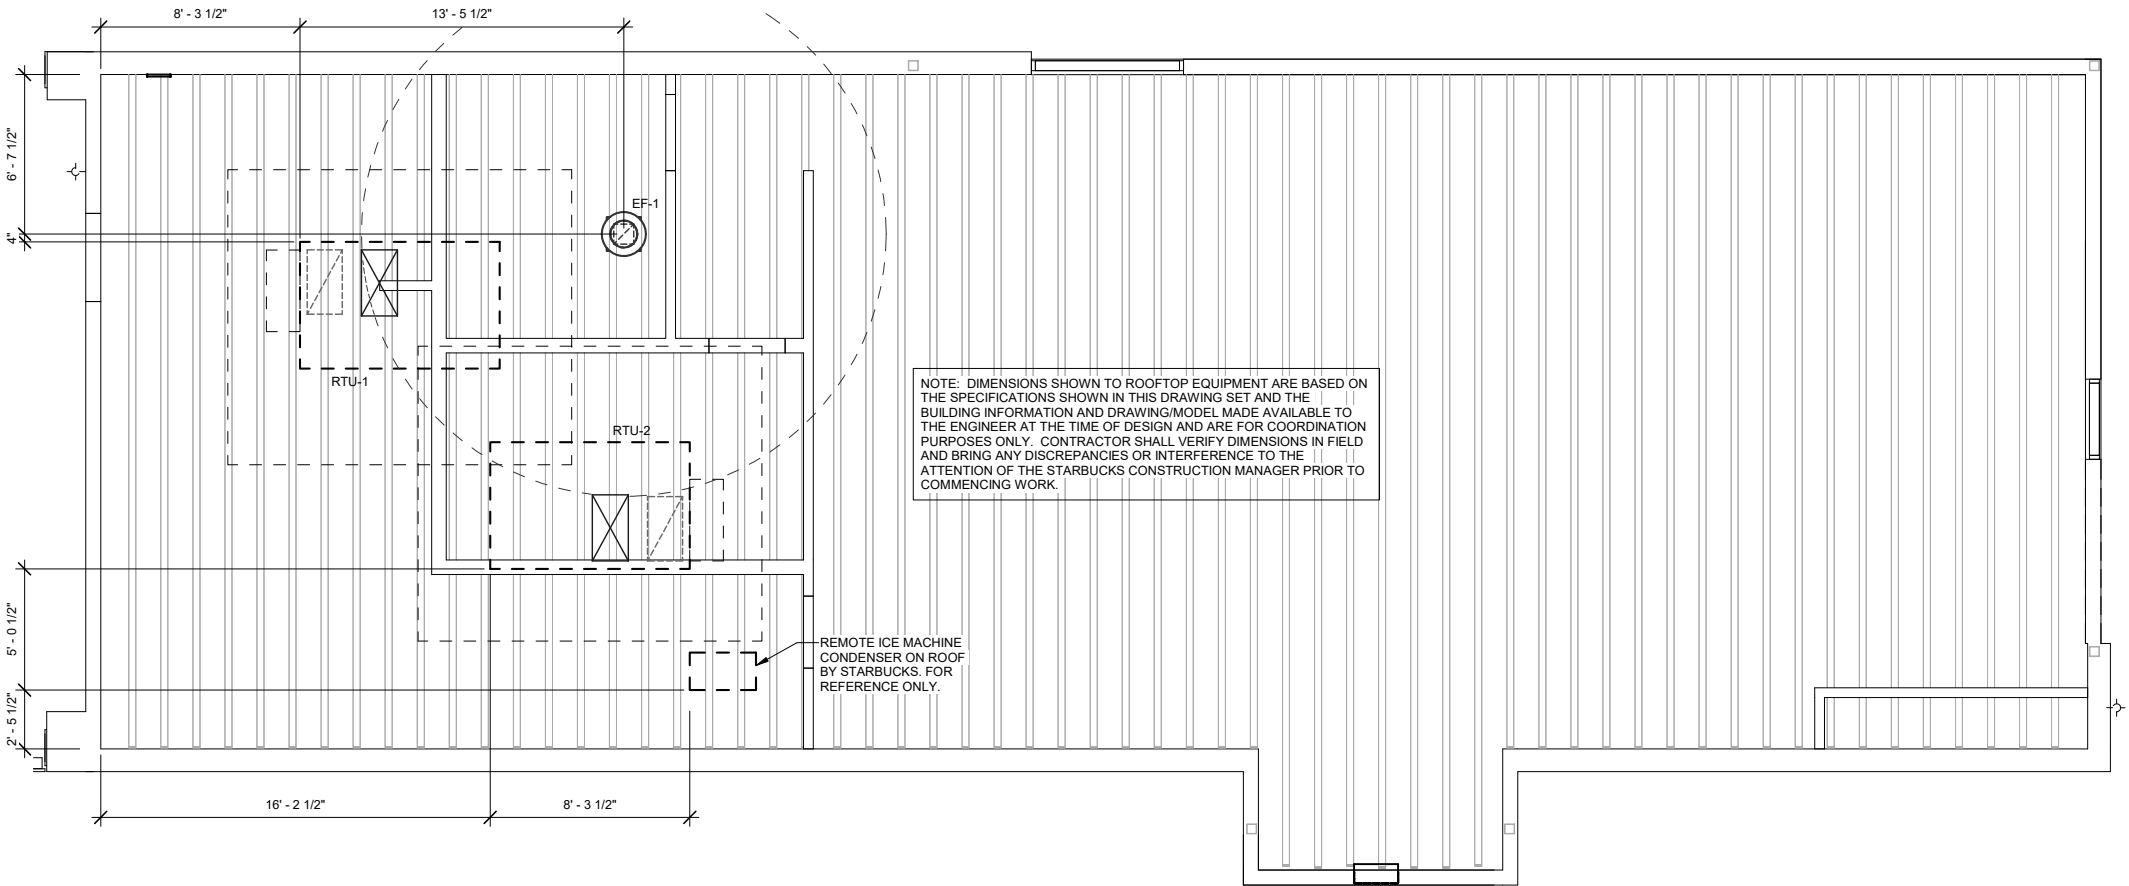

1 PRELIMINARY MECHANICAL PLAN

 1/4" = 1'-0"



DESIGN DEVELOPMENT ONLY - NOT INTENDED FOR CONSTRUCTION USE



© 2018 STARBUCKS COFFEE COMPANY

STARBUCKS®
2401 UTAH AVENUE SOUTH
SEATTLE, WASHINGTON 98134
(206) 318-1575

THESE DRAWINGS AND THE PROJECT MANUAL ARE CONFIDENTIAL AND SHALL REMAIN THE SOLE PROPERTY OF STARBUCKS CORPORATION, WHICH IS THE OWNER OF THE COPYRIGHT IN THIS WORK. THEY SHALL NOT BE REPRODUCED (IN WHOLE OR IN PART), SHARED WITH THIRD PARTIES OR USED IN ANY MANNER ON OTHER PROJECTS OR EXTENSIONS TO THIS PROJECT WITHOUT THE PRIOR WRITTEN CONSENT OF STARBUCKS CORPORATION. THESE DRAWINGS AND SPECIFICATIONS ARE INTENDED TO EXPRESS DESIGN INTENT FOR A PROTOTYPICAL STARBUCKS STORE (WHICH IS SUBJECT TO CHANGE AT ANYTIME) AND DO NOT REFLECT ACTUAL SITE CONDITIONS. NEITHER PARTY SHALL HAVE ANY OBLIGATION NOR LIABILITY TO THE OTHER (EXCEPT STATED ABOVE) UNTIL A WRITTEN AGREEMENT IS FULLY EXECUTED BY BOTH PARTIES.

STARBUCKS TEMPLATE VERSION i2020-01-31

NORR



William J. Alkemeyer, P.E.
353 Marshall Avenue
St. Louis, Missouri 63119
Phone (314) 772-1782
Fax (314) 373-3514

Engineering Consultant

159-21

PROJECT NAME:
I-40 & NC210

PROJECT ADDRESS:
**12321 NC 210 HWY
BENSON, NC 27504
JOHNSTON COUNTY**

STORE #: TBD
PROJECT #: 91320-001
ISSUE DATE: 08.16.2021
SR. DESIGN MANAGER: G. AVILA
PRODUCTION DESIGNER: E. DONCHEVA
CHECKED BY: XXX/XXX

Revision Schedule			
Rev	Date	By	Description

SHEET TITLE:
**PRELIMINARY
MECHANICAL PLAN**
SCALE: AS SHOWN

SHEET NUMBER:
M000